


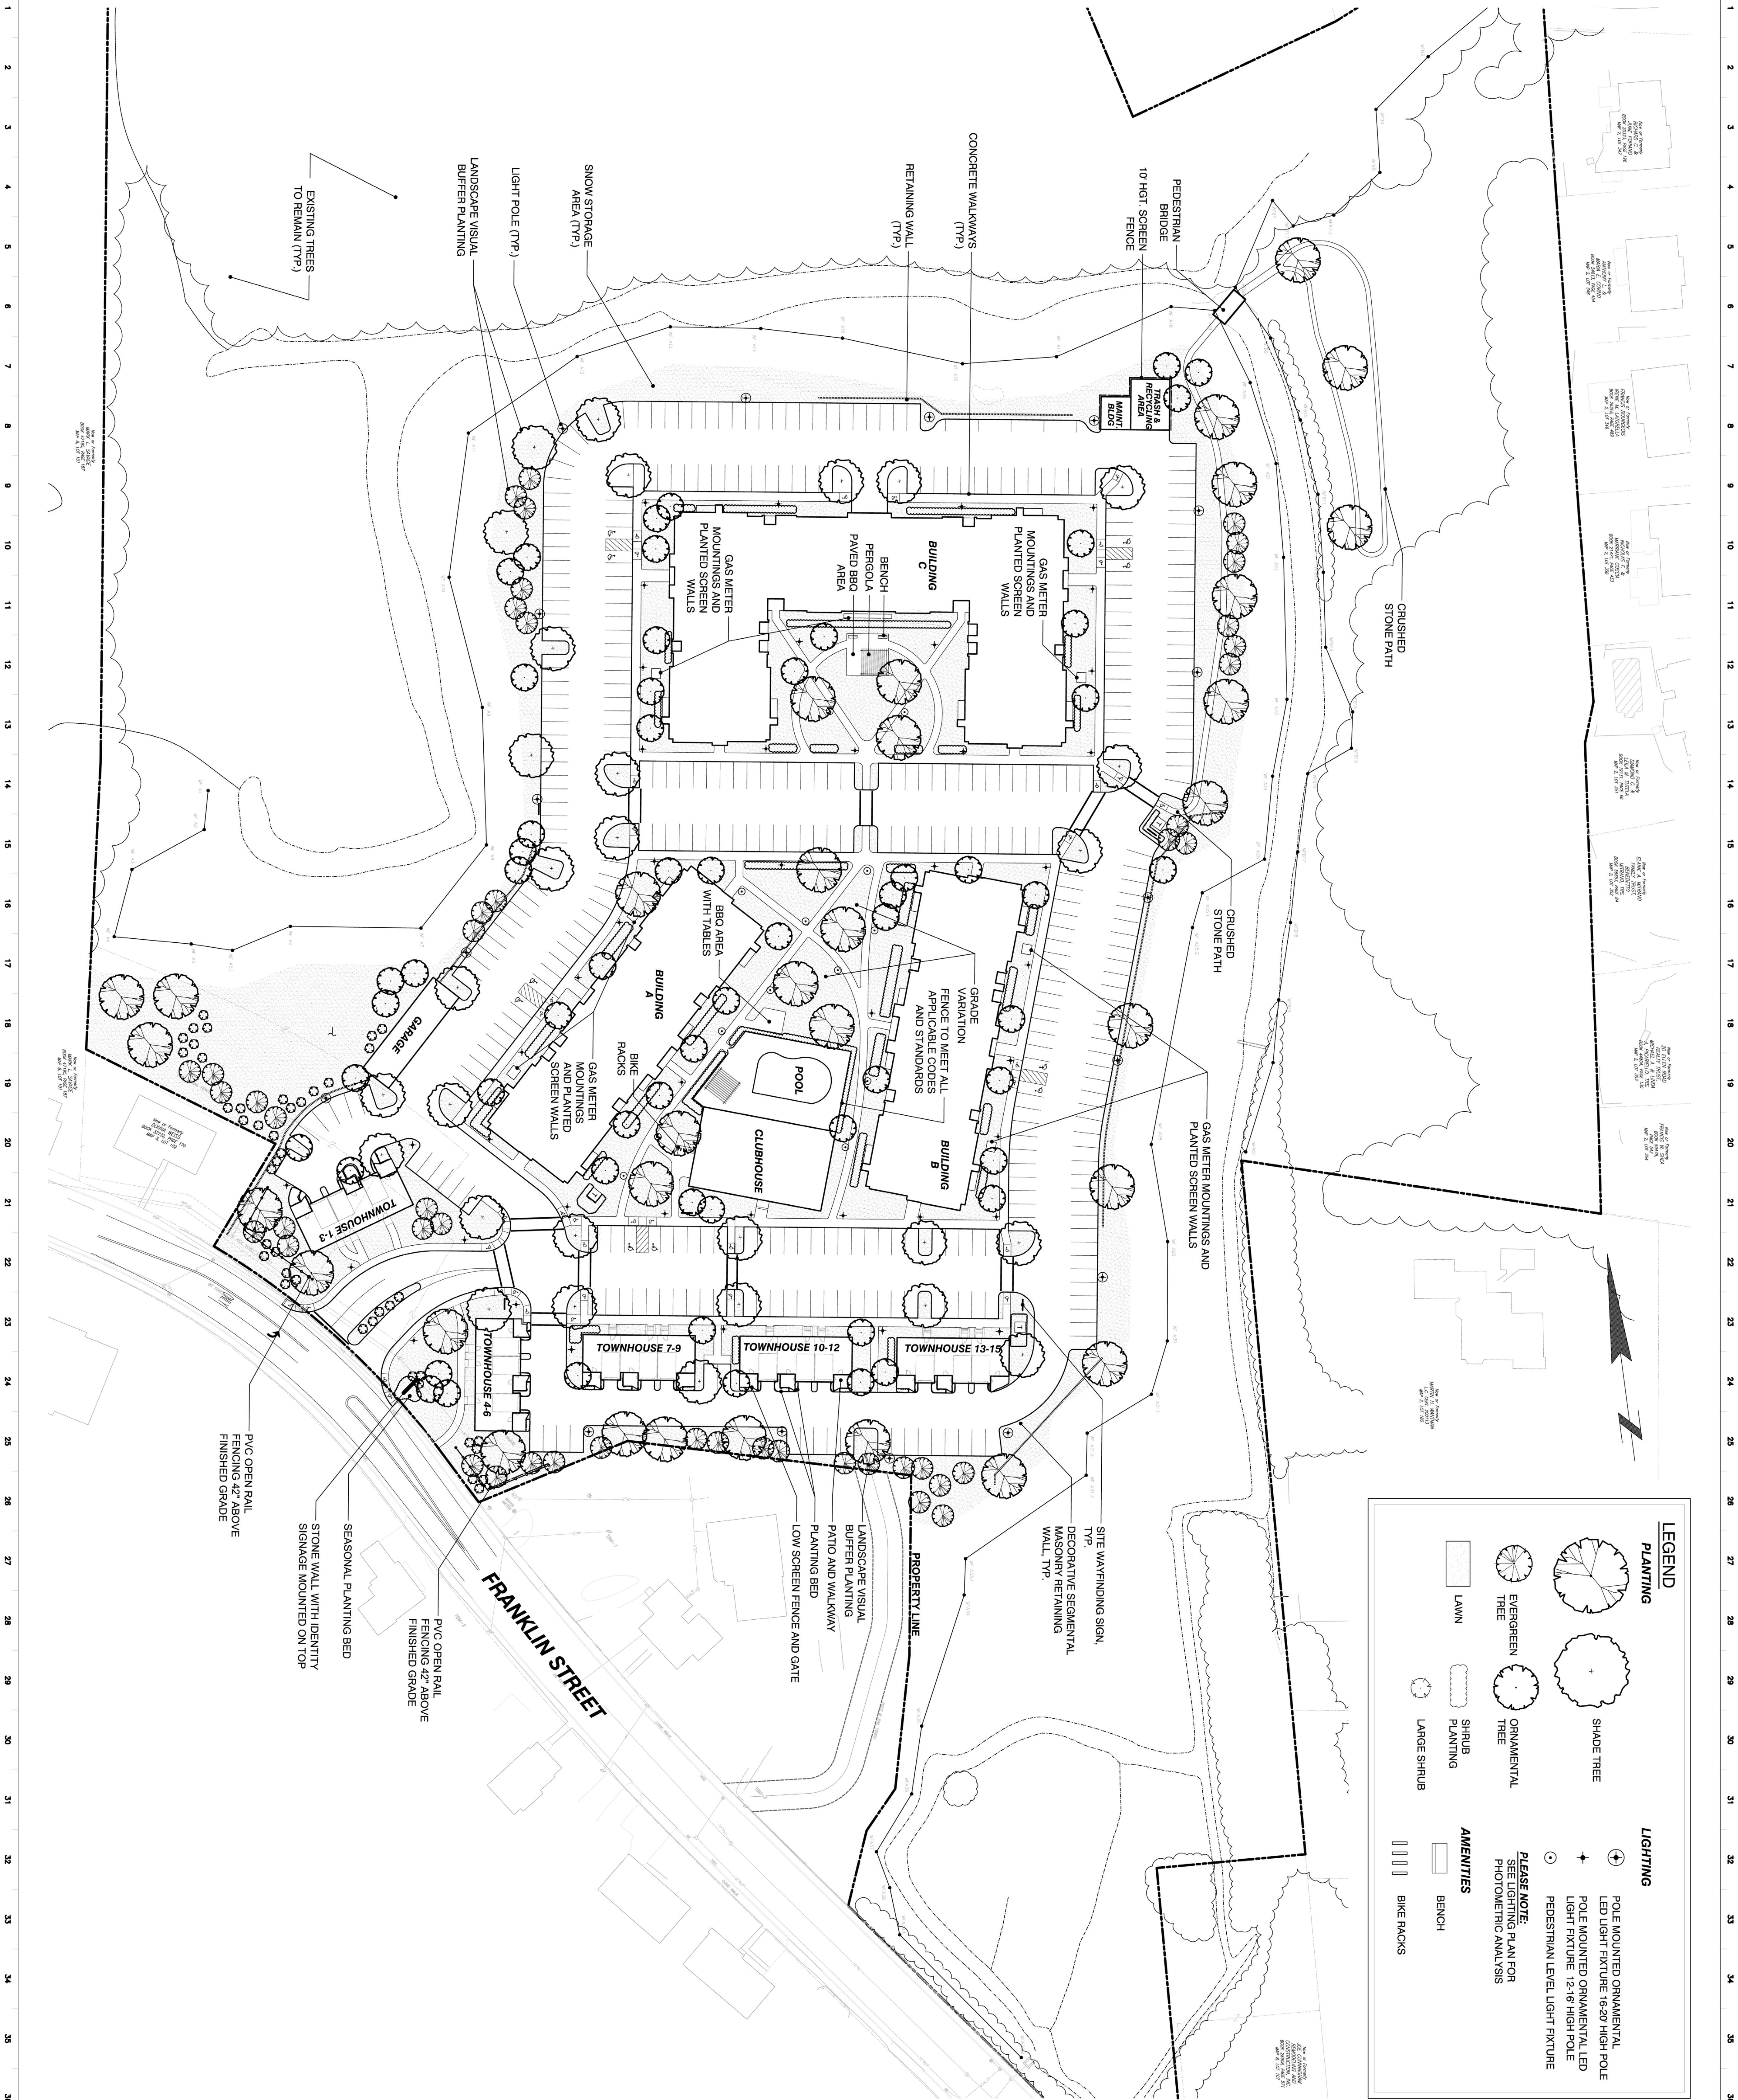

LEGEND

PLANTING

SHADE TREE

EVERGREEN TREE

ORNAMENTAL TREE

SHRUB PLANTING

LARGE SHRUB

LAWN

LIGHTING

POLE MOUNTED ORNAMENTAL LED LIGHT FIXTURE 16-20' HIGH POLE

POLE MOUNTED ORNAMENTAL LED LIGHT FIXTURE 12-16' HIGH POLE

PEDESTRIAN LEVEL LIGHT FIXTURE

AMENITIES

BENCH

BIKE RACKS

PLEASE NOTE:
SEE LIGHTING PLAN FOR
PHOTOMETRIC ANALYSIS

FOR PERMITTING AND
APPROVALS, NOT FOR
CONSTRUCTION

HORIZONTAL GRAPHIC SCALE IN FEET

REVISIONS

ISSUE	DATE	DESCRIPTION

THE CECIL GROUP
No. 872
Professional Seal

DATE: JUNE 20, 2014

SCALE: 1" = 40'

SHEET L-1

THE COMMONS AT
WEISS FARM
STONEHAM, MASSACHUSETTS

The Cecil Group
Planning and Design
170 Milk Street, STE 5 | 617.426.5050
Boston, MA 02210 | 617.426.5051